

three inches = one foot
one and one half inches = one foot
one quarter inch = one foot
three quarter inch = one foot
one half inch = one foot
three eighth inch = one foot
one eighth inch = one foot


Table with columns: SPLIC SECTION, FINISH DIVISION, MATERIAL, CODE, NOTES. Includes items like INTERIOR FINISH CARPENTRY, PHENOLIC RESIN PANEL, WOOD DOOR, CASEWORK, PLASTIC LAMINATE, STEEL, INTERIOR SOLID SURFACE WALL PANELING, SOLID POLYMER FABRICATIONS, INTERIOR GLAZING, PORCELAIN WALL TILE, CERAMIC WALL TILE, PORCELAIN FLOORING TILE.

Table with columns: SPLIC SECTION, FINISH DIVISION, MATERIAL, CODE, NOTES. Includes items like DALTILE KEYSTONE PENNY ROUND RANDOM BLEND, QUARRY TILE, GROUT, MARBLE, PUBLIC RESTROOM COUNTER TOPS, RESILIENT FLOORING, LINOLEUM SHEET, RUBBER TREADS, RUBBER LANDING, EPOXY TERRAZZO, CARPET TILE, WALLCOVERING, ACCOUTICAL WALL PANELS, FABRIC WRAPPED PANELS.

Table with columns: SPLIC SECTION, FINISH DIVISION, MATERIAL, CODE, NOTES. Includes items like PAINT, CORNER GUARD, CRASH RAIL, RIBBON SHEET WAINSCOT, HANDRAIL, WINDOW SHADE, CURTAIN, GELING, ACUSTICAL CEILING, GYPSUM, SERVICE ELEVATOR CAB, FLOORING.

NOTES

- 1. INFORMATION IN COLOR AND MATERIAL LOCATION PLANS IS FOR COLOR AND PATTERN ONLY.
2. WHERE COLORS ARE NOT NOTED WITH A SPECIFIC COLOR CODE, REFER TO THE TYPICAL. SEE COLOR SCHEDULE.
3. SEE A1200 SERIES INTERIOR ELEVATIONS AND AF620 ROOM FINISH SCHEDULES FOR ADDITIONAL INFORMATION.
4. USE COVE BASE AT ALL TOILET ROOMS, MATCH WITH FLOOR TILE COLOR AND FINISH, TYPICAL, EXCEPT AT SINGLE TOILETS AND FAMILY TOILETS, MATCH WITH WALL TILE COLOR AND FINISH.
5. 4" WALL BASE AT ALL ROOMS AND HALLWAYS, TYP. 6" WALL BASE AT MAIN PUBLIC AREAS AND HALLWAYS IN SOUTH SIDE OF THE BUILDING.
6. FW10 AT RECEPTION DESK TACKBOARD ABOVE COUNTERTOP, TYP.
WALL NOTES
7. IN GH10, 1H10, 1H90, 2H10, 2H90, 3H10, 3H90, 4H10, 4H90, 5H90, P5 ON NORTH WALL ABOVE WDW, P8 ON SOUTH WALL ABOVE PW11, IN 1W15 & 2W1, P5 ON SOUTH WALL ABOVE WDW.
8. P-09 AT STRUCTURAL BRACING IN MAIN PUBLIC COORIDORS, P-15 AT STRUCTURAL BRACING INSIDE OF ROOMS, U.O.N.
9. EGG SHELL WALL & SOFFIT PAINT FINISH TYPICAL, SEMI-GLOSS WALL PAINT FINISH AT PLUMBING FIXTURE WALLS AND ALL RESTROOMS, EPOXY WALL PAINT FINISH AT LABS, HVAC ROOMS, TISSUE CULTURE ROOMS, MICROSCOPE ROOMS, WASHROOM, LAB EQUIPMENT ROOMS. SEE ROOM FINISH SCHEDULE.
10. 4"-8" AFF VERTICAL SURFACE AT SINK WALL IN EXAM/TREAT ROOMS, UNLESS OTHERWISE NOTED.
11. PAINT WOOD DOOR FRAMES P-14, TYP., U.O.N.
12. PAINT HOLLOW METAL DOORS AND FRAMES TO MATCH ADJACENT WALL FINISH, U.O.N.
FLOORING NOTES
13. WHERE DIFFERING FLOOR FINISH MATERIALS MEET AT DOORS, THE SEAM SHALL OCCUR DIRECTLY BELOW THE CENTERLINE OF THE CLOSED DOOR, UNLESS OTHERWISE NOTED.
14. LENGTH / GRAIN OF FLOOR SHEET GOODS TO BE IN CONSISTENT DIRECTION FOR ANY ONE AREA, TYP.
15. FOR ELECTRICAL CLOSET, CONTINUE LINOLEUM FLOORING IN THE HALLWAYS. EPOXY IS TYPICAL.
16. USE MONOLITHIC INSTALLATION METHOD FOR CARPET TILES.
CEILING NOTES
17. GYPSUM BOARD SOFFITS, PAINT FACE WITH PAINT COLOR CODE, SEE INTERIOR FINISH PLANS.
WINDOW SHADE NOTES
18. PROVIDE WINDOW SHADES AT ALL EXTERIOR GLAZING WITH THE EXCEPTION OF HALLWAYS #1H10, 1H90, 2H10, 2H90, 3H10, 3H90, 4H10, 4H90, 5H10 AND 5H90, AS SPECIFIED IN SECTION 12 24 00.
19. TYPE A, TYPICAL, TYPE B AT GW25, GW30, 1W85, 1E90, 1E20, 2W85, 3W70, 3W03, 3W05, 4W10, 4W20, 4W34, 5W15, 5W70. SEE REFLECTED CEILING PLANS FOR ALL LOCATIONS.
GLAZING NOTES
20. GL5 CLEAR GLASS, TYPICAL, UNLESS OTHERWISE NOTED.
21. FOR TYPICAL OFFICE DOORS, GL4 AT DOORS AND GL5 AT TRANSOM.
PLASTIC LAMINATE AT SANITIZER STATIONS
22. HPD1 TYPICAL HPD3 AT ELEVATOR LOBBY ON ALL LEVELS AND AT GRIDLINE S & 1-3 ON EVERY LEVEL. HPDLS AT WAIT 1W11.

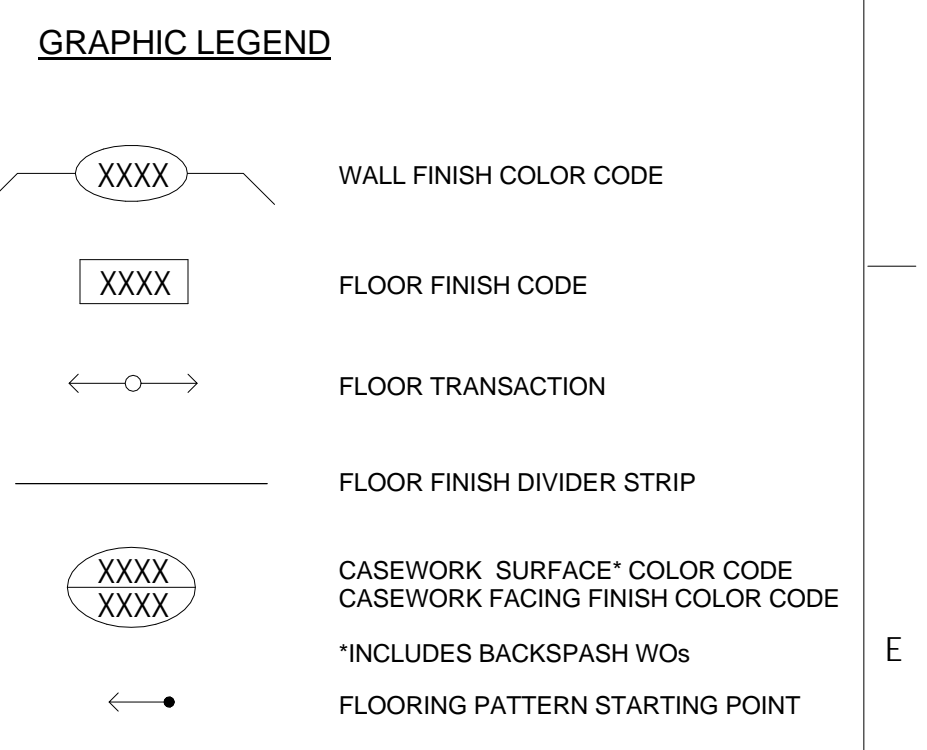

CONSULTANTS:
AMENDMENT A00004 07.14.2014
AMENDMENT A00003 07.02.2014
BID DOCUMENTS 05.30.2014
CONSTRUCTION DOCUMENT CD2 06.05.2013

ARCHITECT
STANTEC THE DESIGN PARTNERSHIP
8454 REGISTERED ARCHITECT
STATE OF WASHINGTON

Drawing Title: MH&R - INTERIOR COLOR SCHEDULE
Drawing Scale: 1/4" = 1'-0"
Approved: Project Director

Project Title: Building 101 Mental Health Services VAPSHCS Seattle
Building Number: B101 Mental Health Services
Location: 1660 South Columbian Way, Seattle, WA 98105
Date: JUNE 05, 2013
Checked: AL
Drawn: SAHH

Office of Construction and Facilities Management
Department of Veterans Affairs
CONSTRUCTION DOCUMENT 2 FULLY SPRINKLERED
Project Number: VAF 663-405B
Building Number: B101 Mental Health Services
Drawing Number: AF100
Volume 2a